
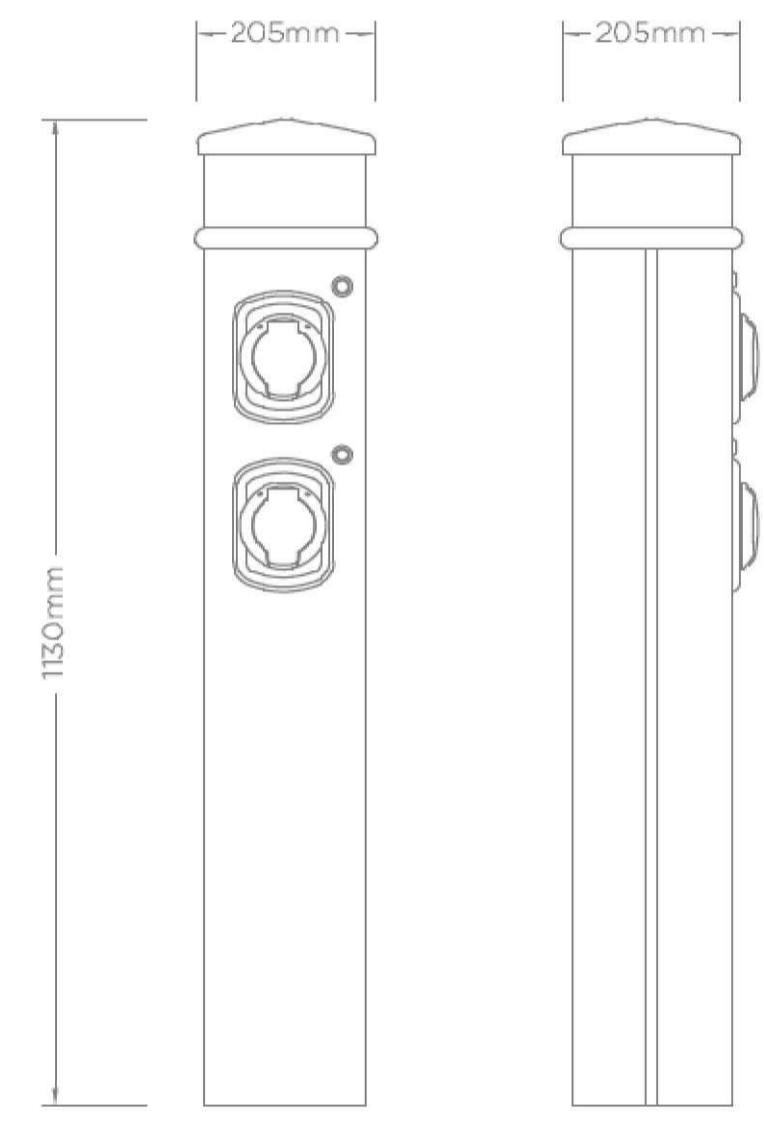


- Dimensions are in millimeters, unless stated otherwise.
 - Scaling of this drawing is not recommended.
 - It is the recipient's responsibility to print this document to the correct scale.
 - All relevant drawings and specifications should be read in conjunction with this drawing.

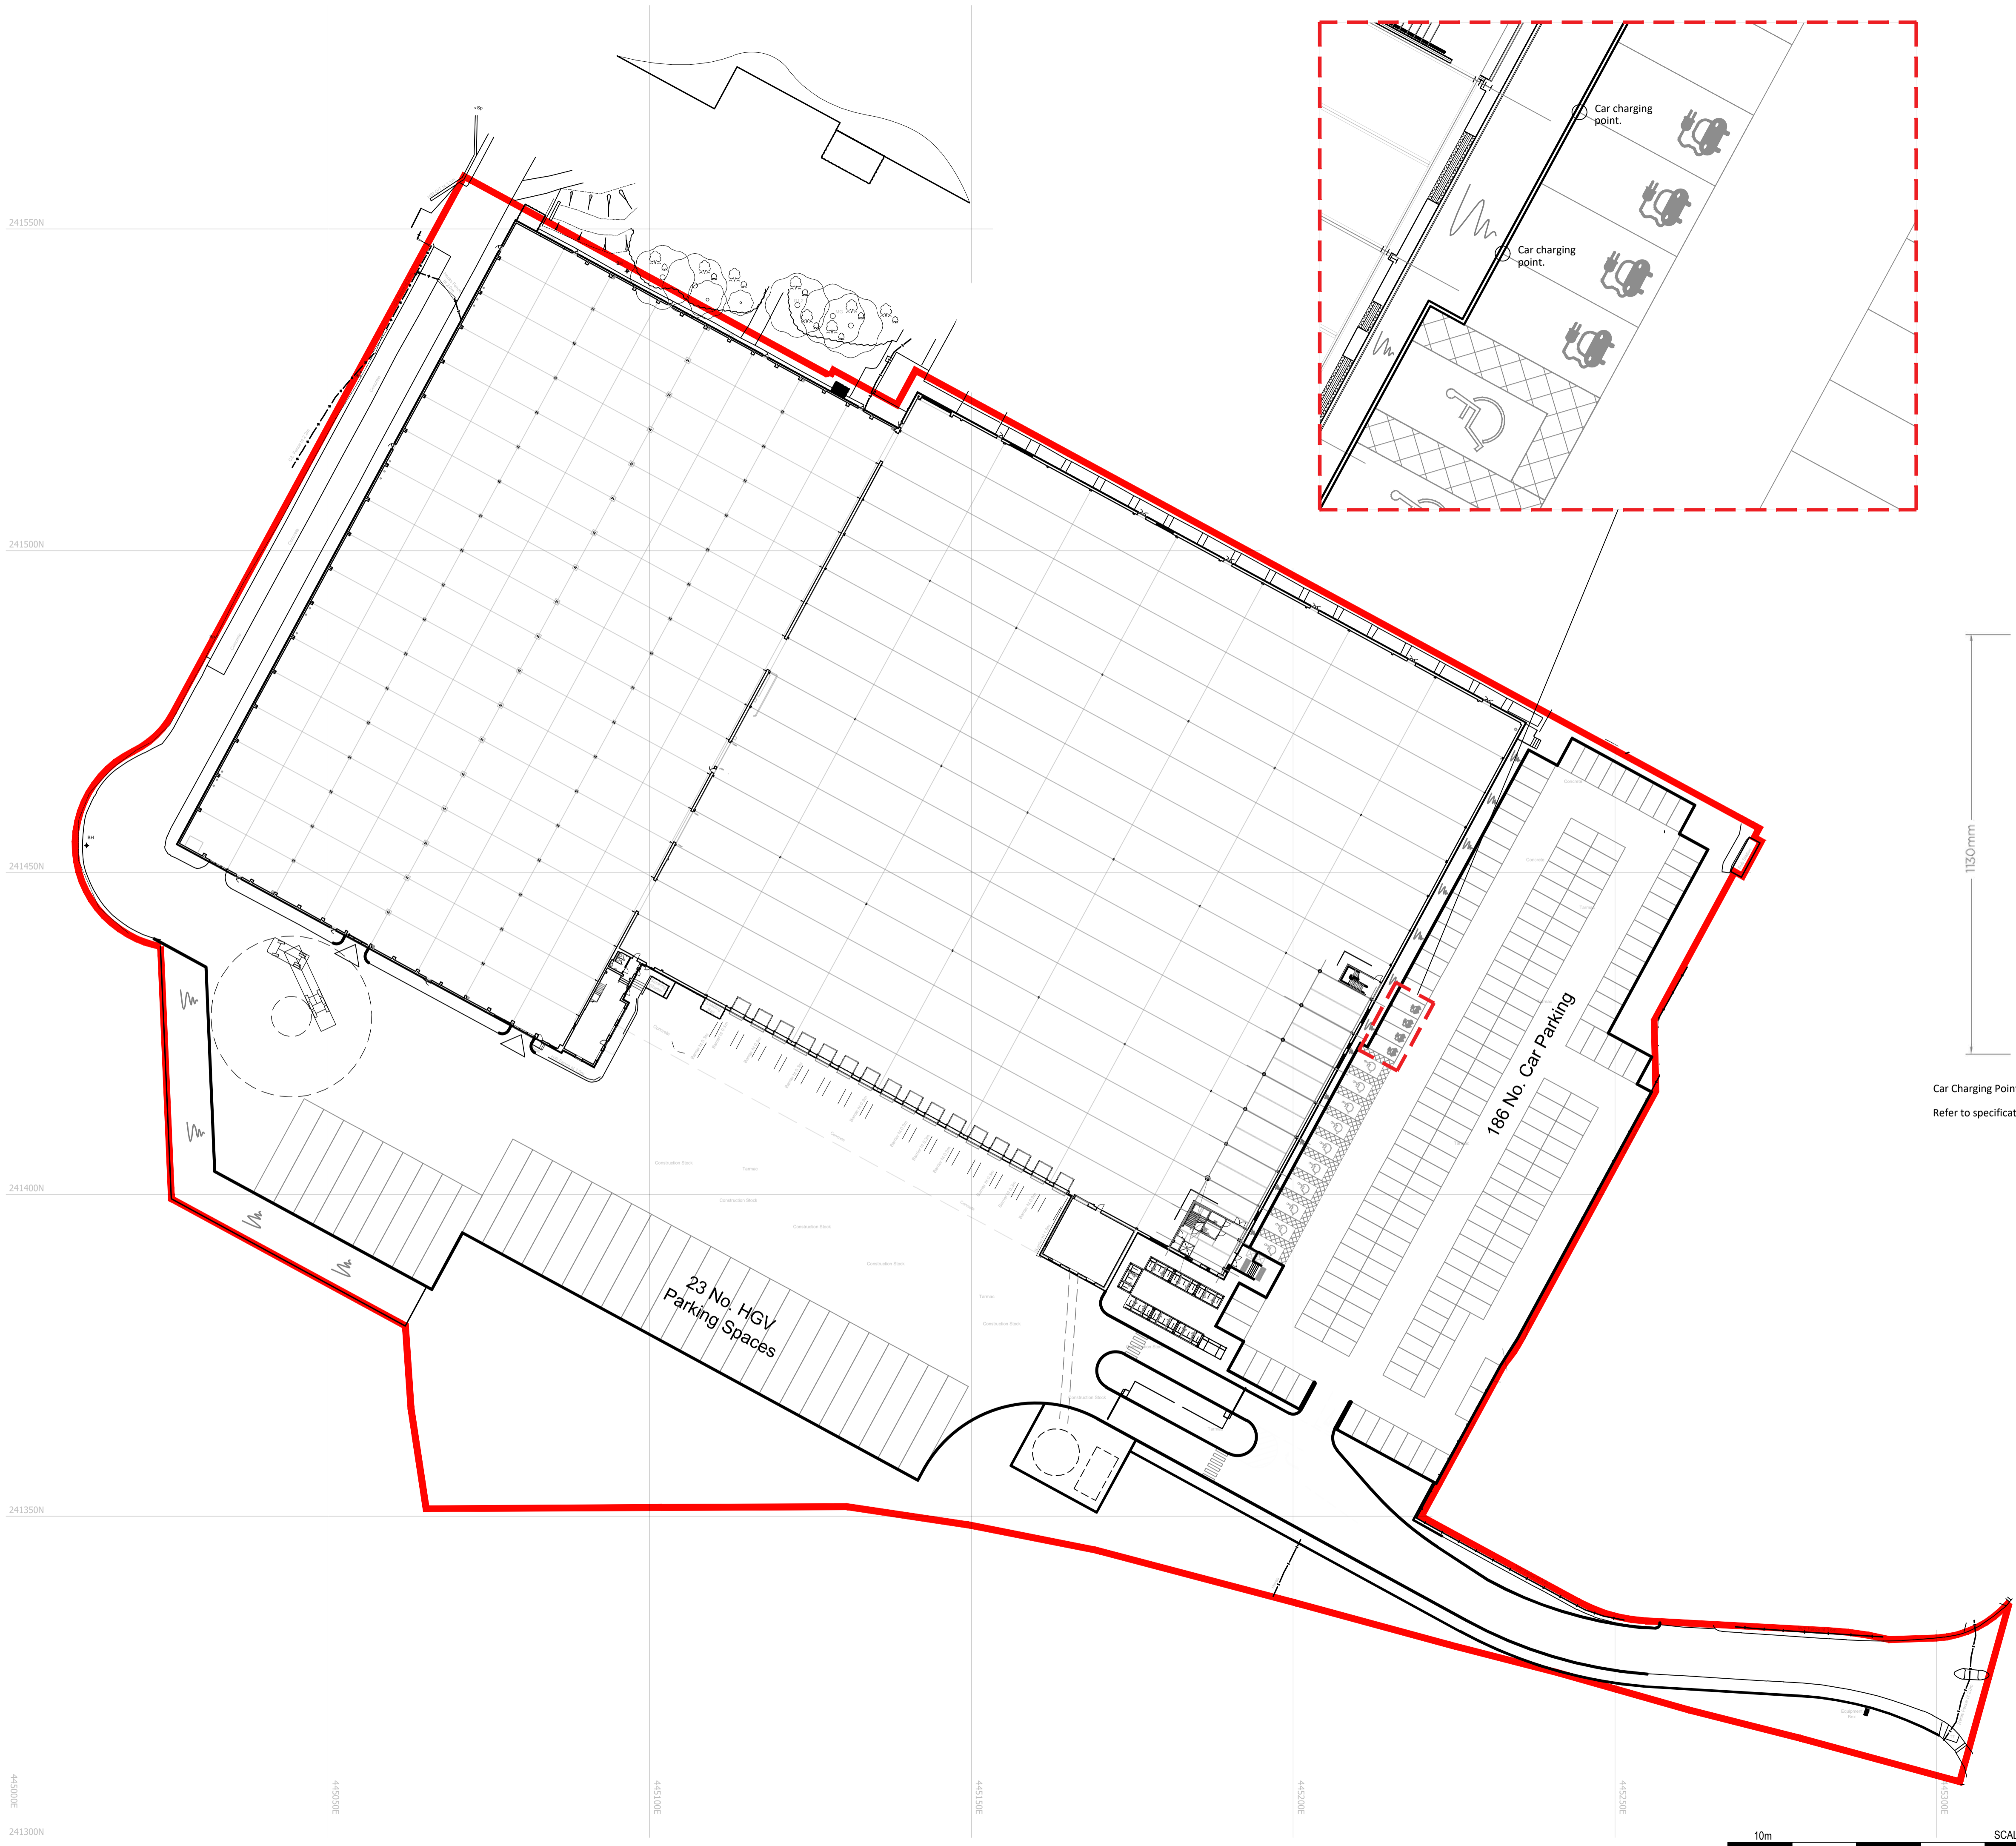

Car Charging Point to be Rolecserv BASICCHARGE:EV pedestal charging point.
 Refer to specification sheet for details.

rev | amendments | by | ckd | date

**Banbury 200 Unit,
 Southam Road, Banbury**
 Proposed Site Plan



Newark Beacon Innovation Centre, Calfenla Way, Newark, Nottinghamshire NG24 2TN
 +44 (0)1636 653027 +44 (0)1636 653010 info@umcarchitects.com

Drawing Status:	Planning
Drawn / Checked:	DG / AS
Date:	03.01.19
Scale:	1:500 A1
Drawing no:	Revision:
16083 P0021	-